


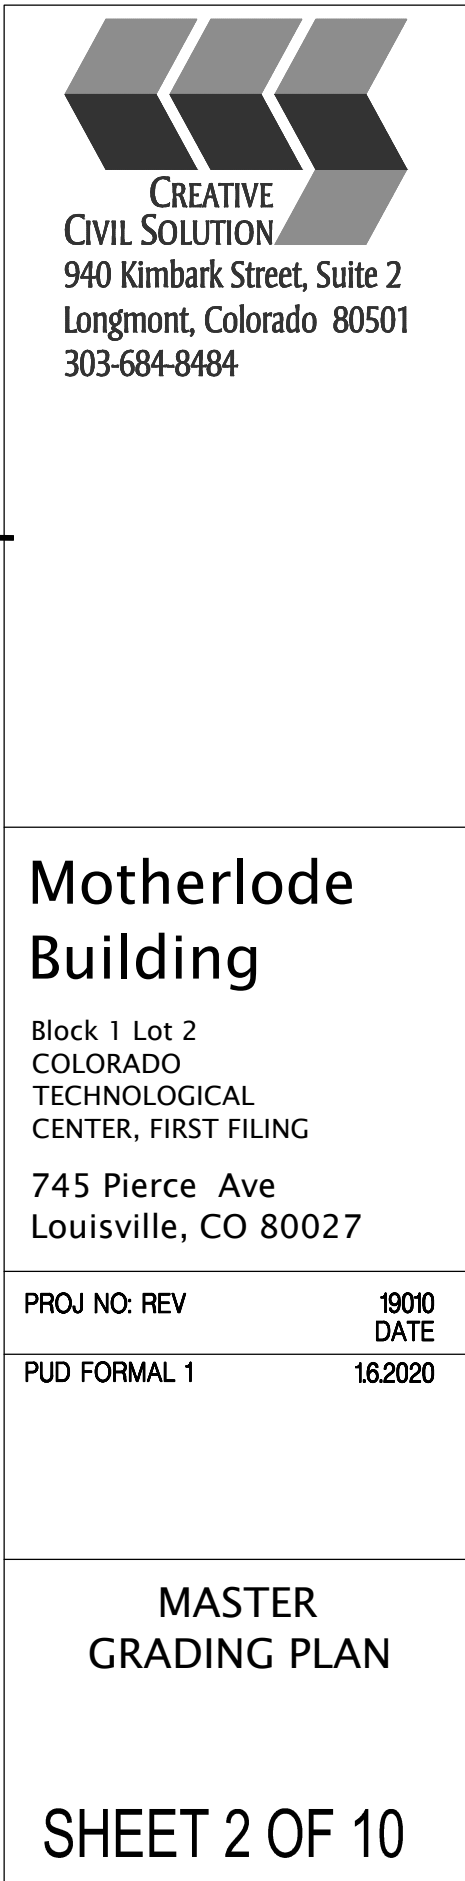

MOTHERLODE BLDG
BLOCK 1 LOT 2 CTC, FIRST FILING
745 PIERCE AVE.
LOUISVILLE CO 80027

REVISIONS:

△	
△	
△	
△	
△	

DRAWN BY: CHECKED BY:

KDA **KDA**

DATE: 2020-01-06


PHASE: PUD

JOB NUMBER: 2019045


DRAWING TITLE:
PUD DEVELOPMENT PLAN

DRAWING NUMBER:

SHEET 4 OF 10

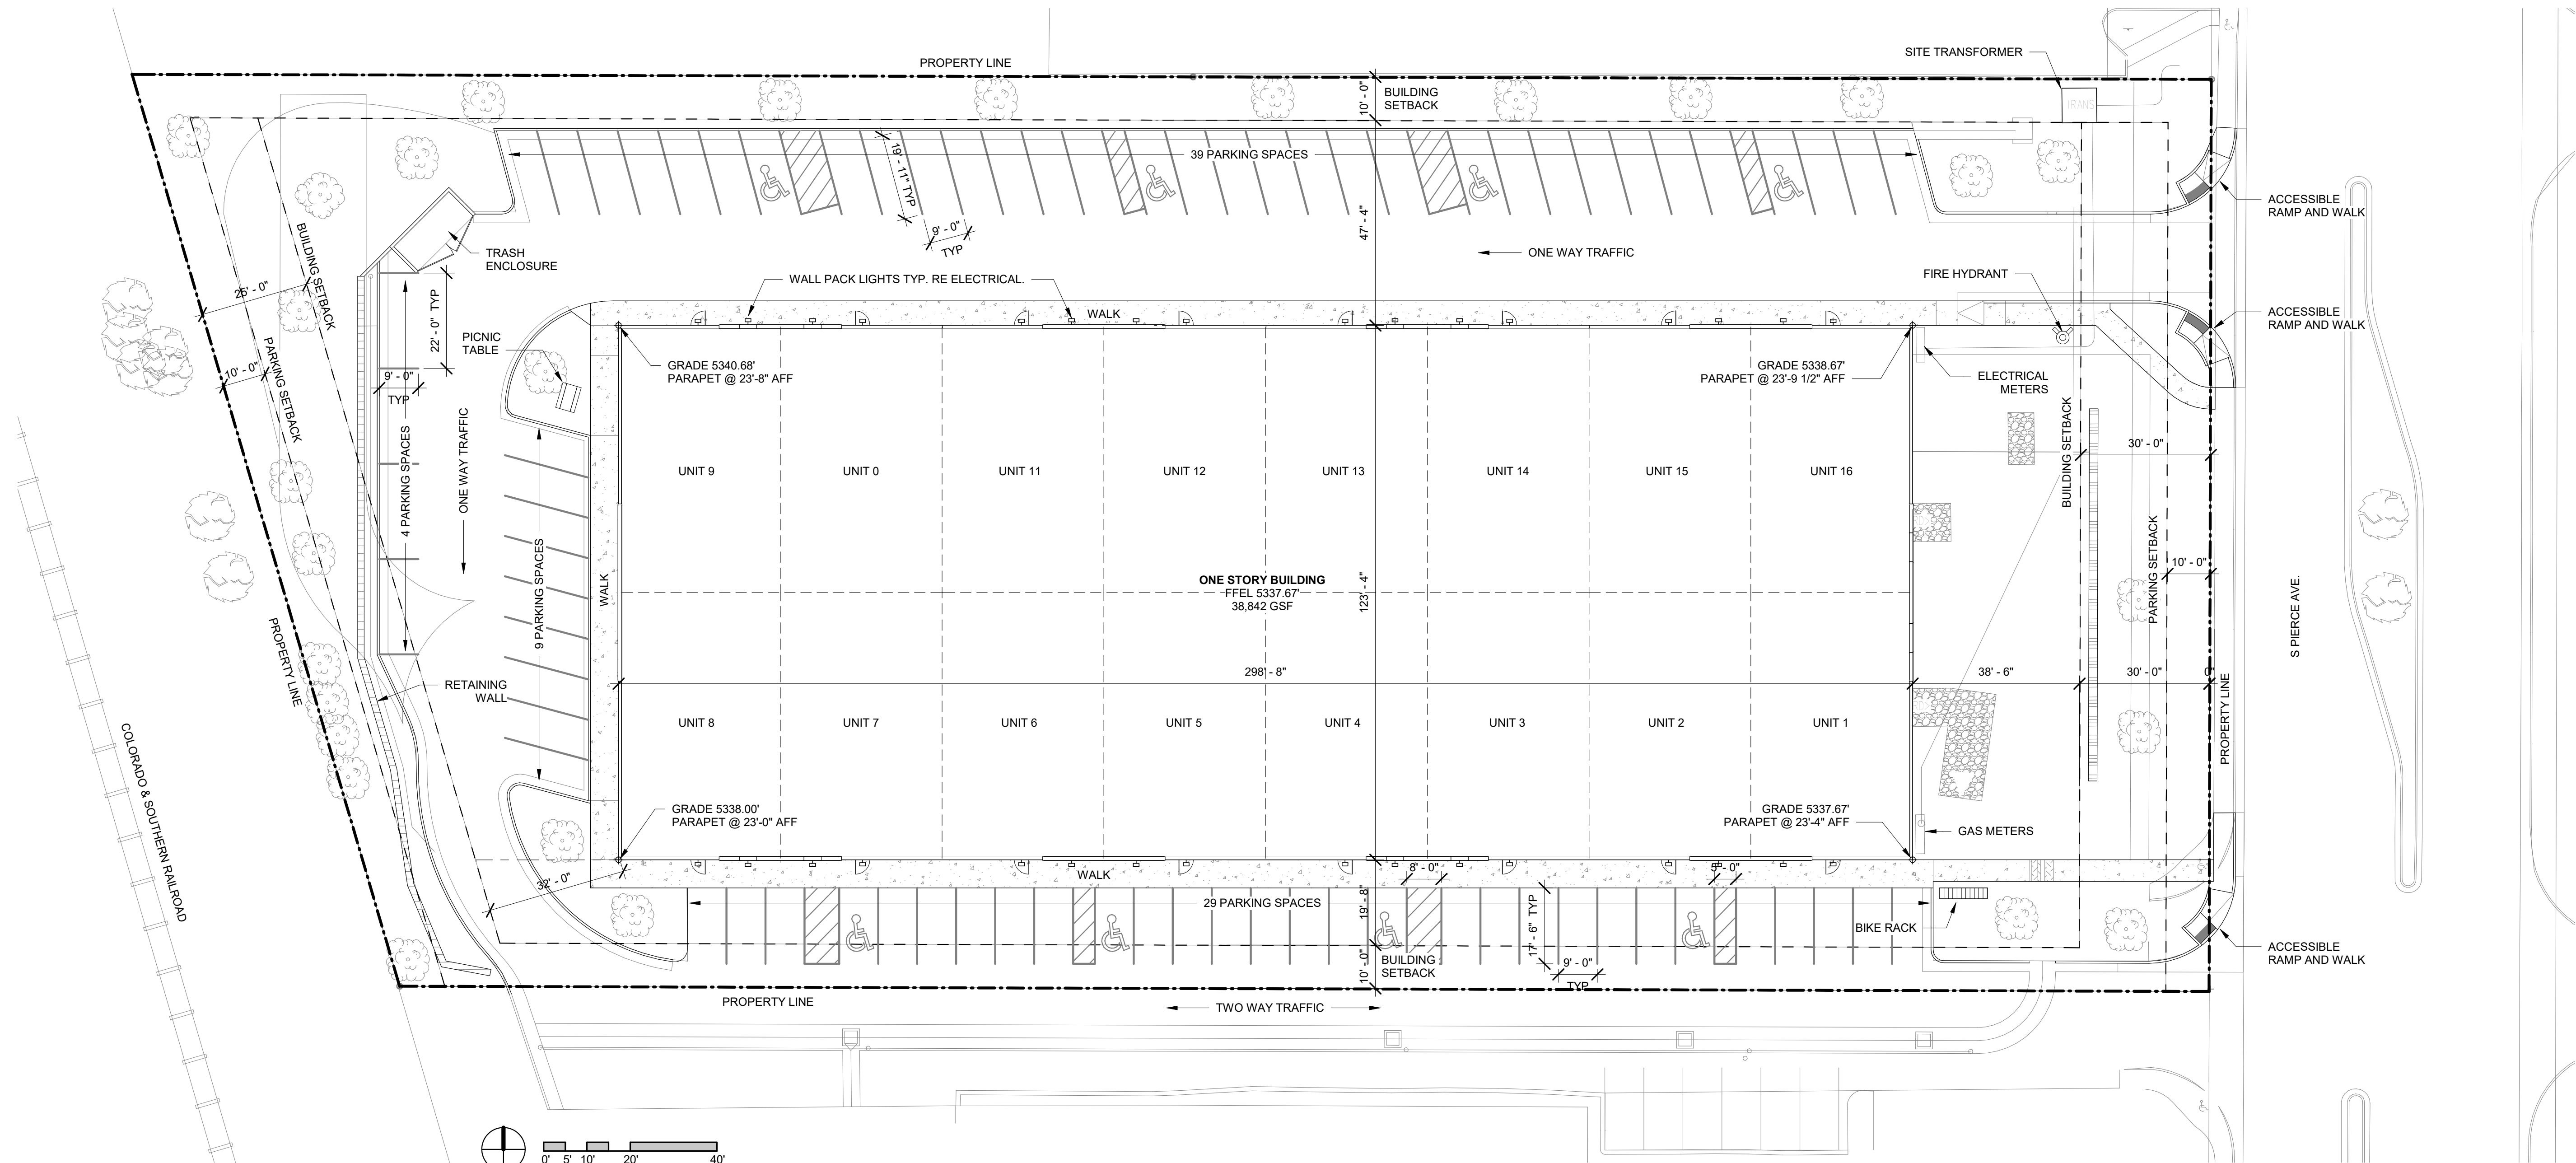

1 ARCHITECTURAL SITE PLAN
1" = 20'-0"

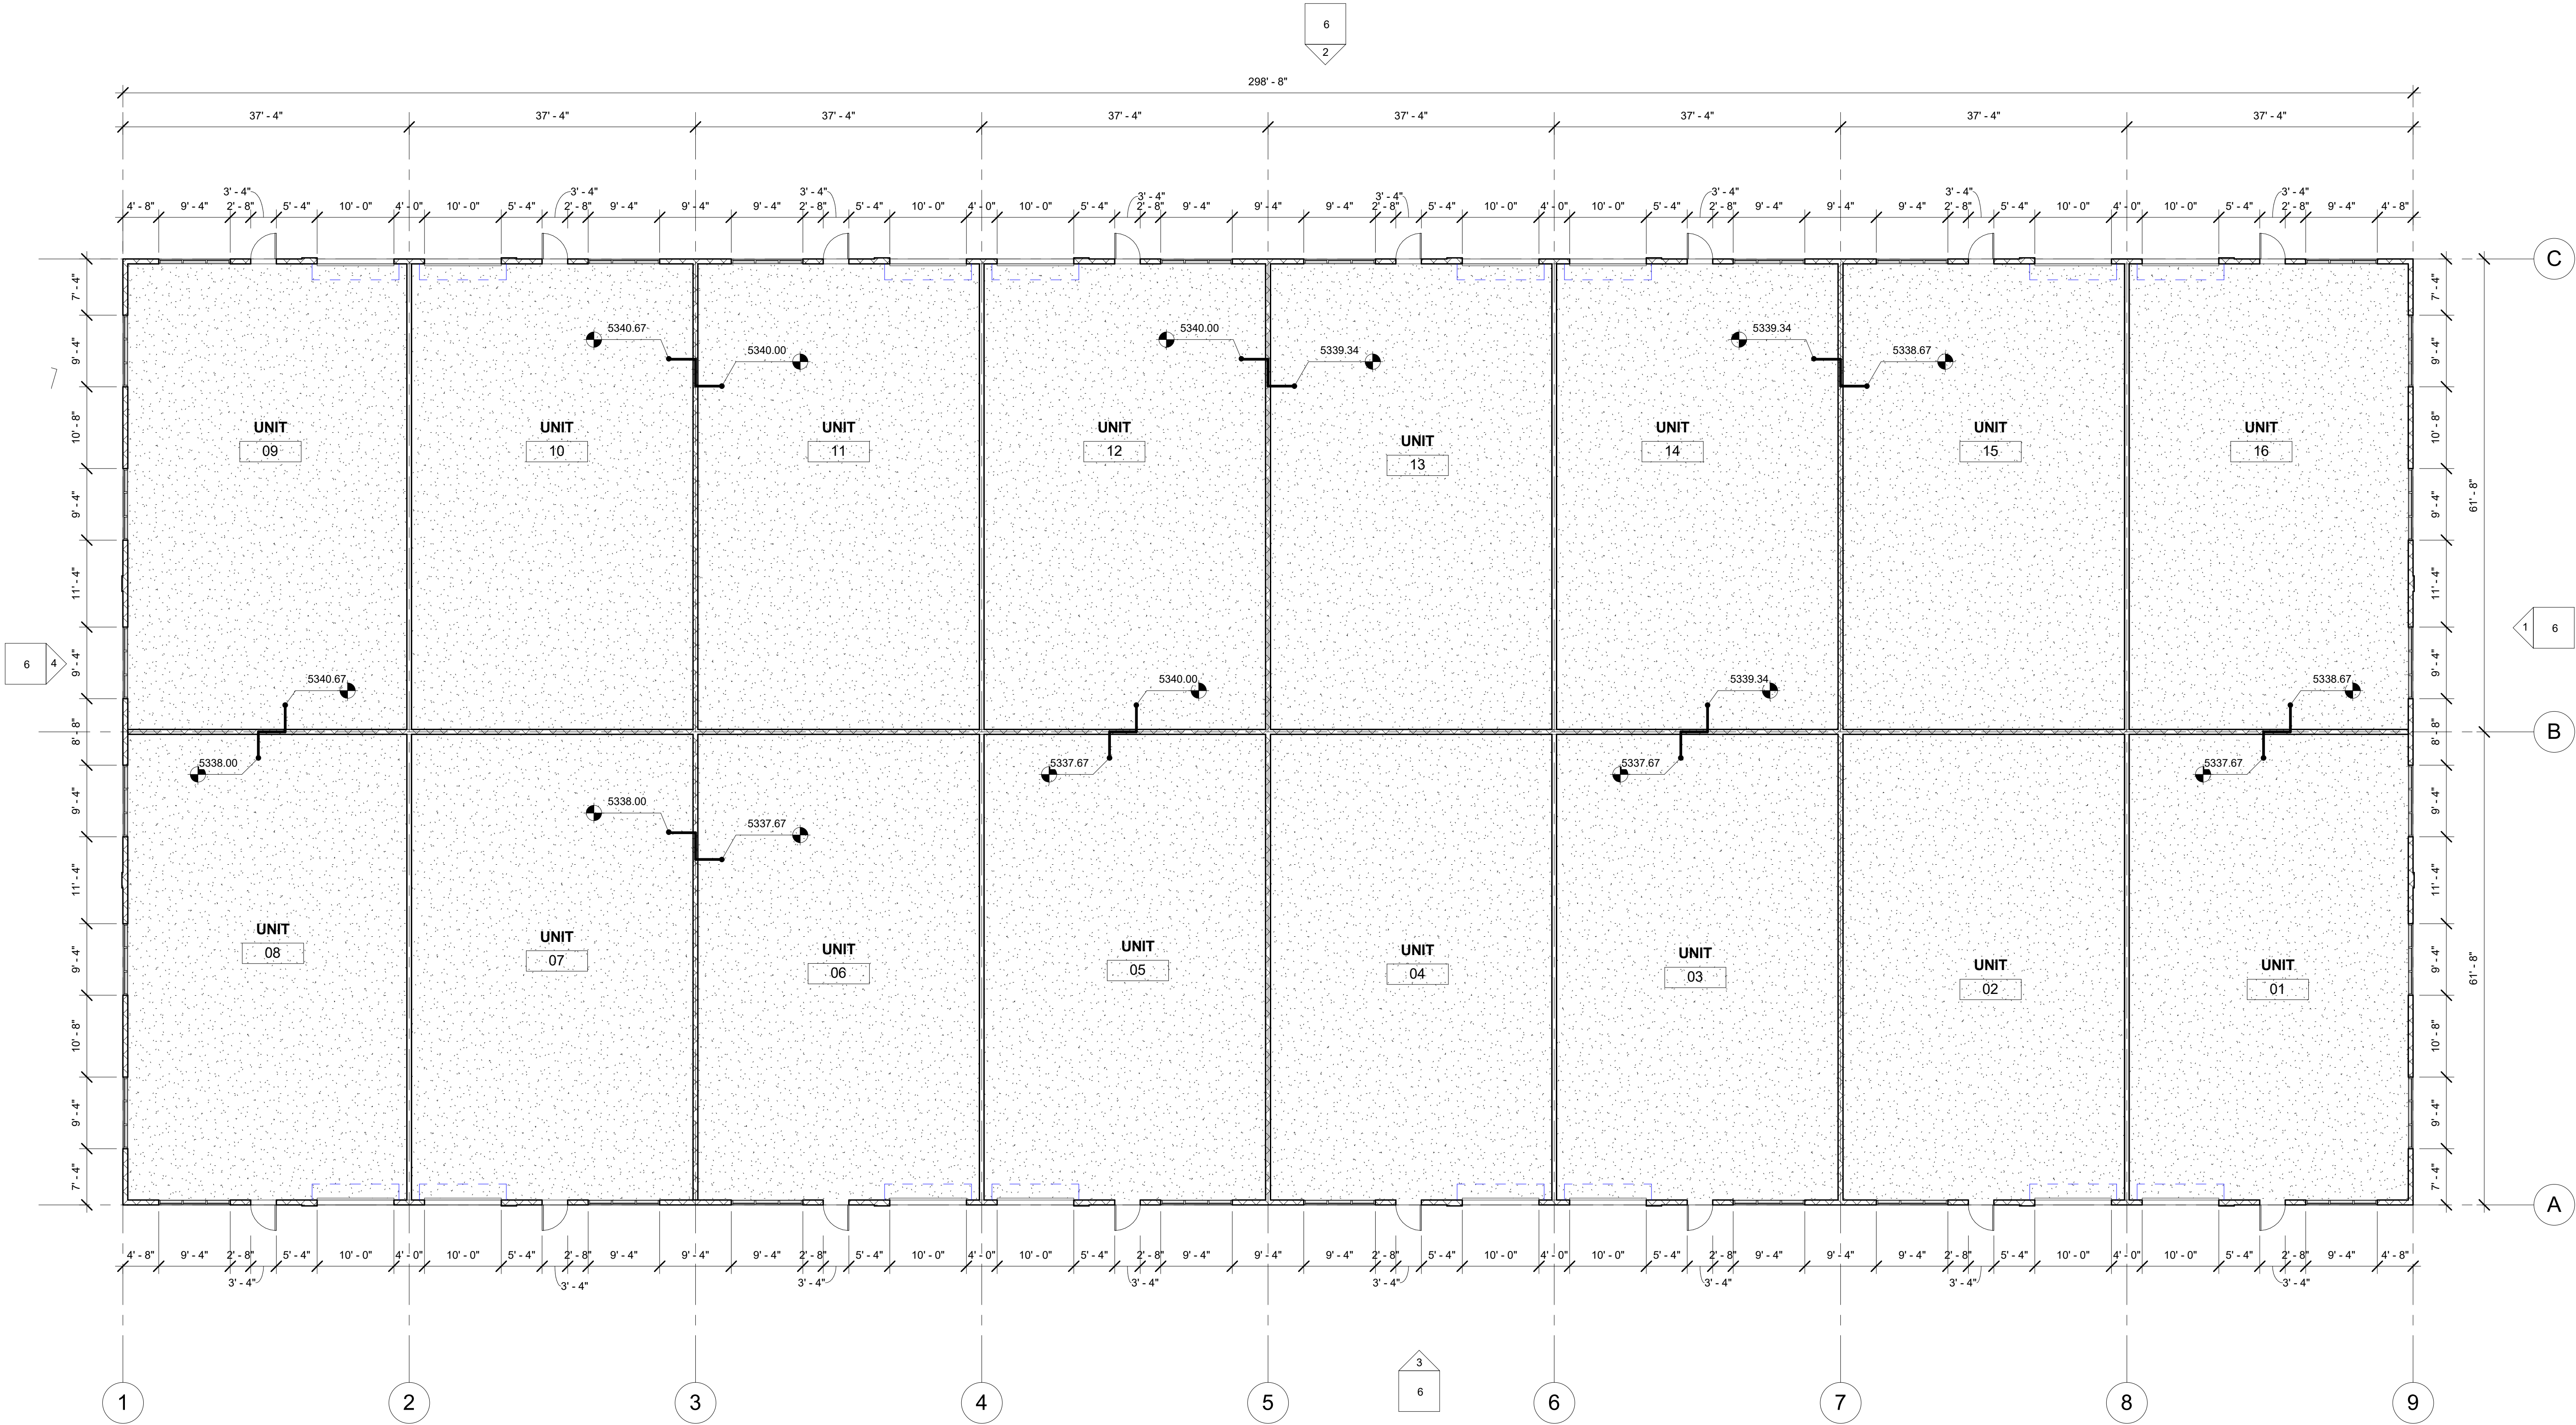

1 LEVEL 1
3/32" = 1'-0"

Kenny Davis Architects

1638 South Brentwood, Lakewood, Colorado, 80232 Tel: 303.465.5813

professional seal

Copyright Notice: This document and the ideas and designs incorporated herein are given in confidence and shall be used only pursuant to the agreement with Kenny Davis Architects. No other use, dissemination or duplication may be made without prior written consent of Kenny Davis Architects. All common law rights of copyright are hereby specifically reserved.

consultant

MOTHERLODE BLDG
BLOCK 1 LOT 2 CTC, FIRST FILING
745 PIERCE AVE.
LOUISVILLE CO 80027

REVISIONS:	
△	
△	
△	
△	
△	

DRAWN BY: CHECKED BY:

KDA KDA

DATE: 2020-01-06


PHASE: PUD

JOB NUMBER: 2019045


DRAWING TITLE: FLOOR PLAN

DRAWING NUMBER:


SHEET 5 OF 10

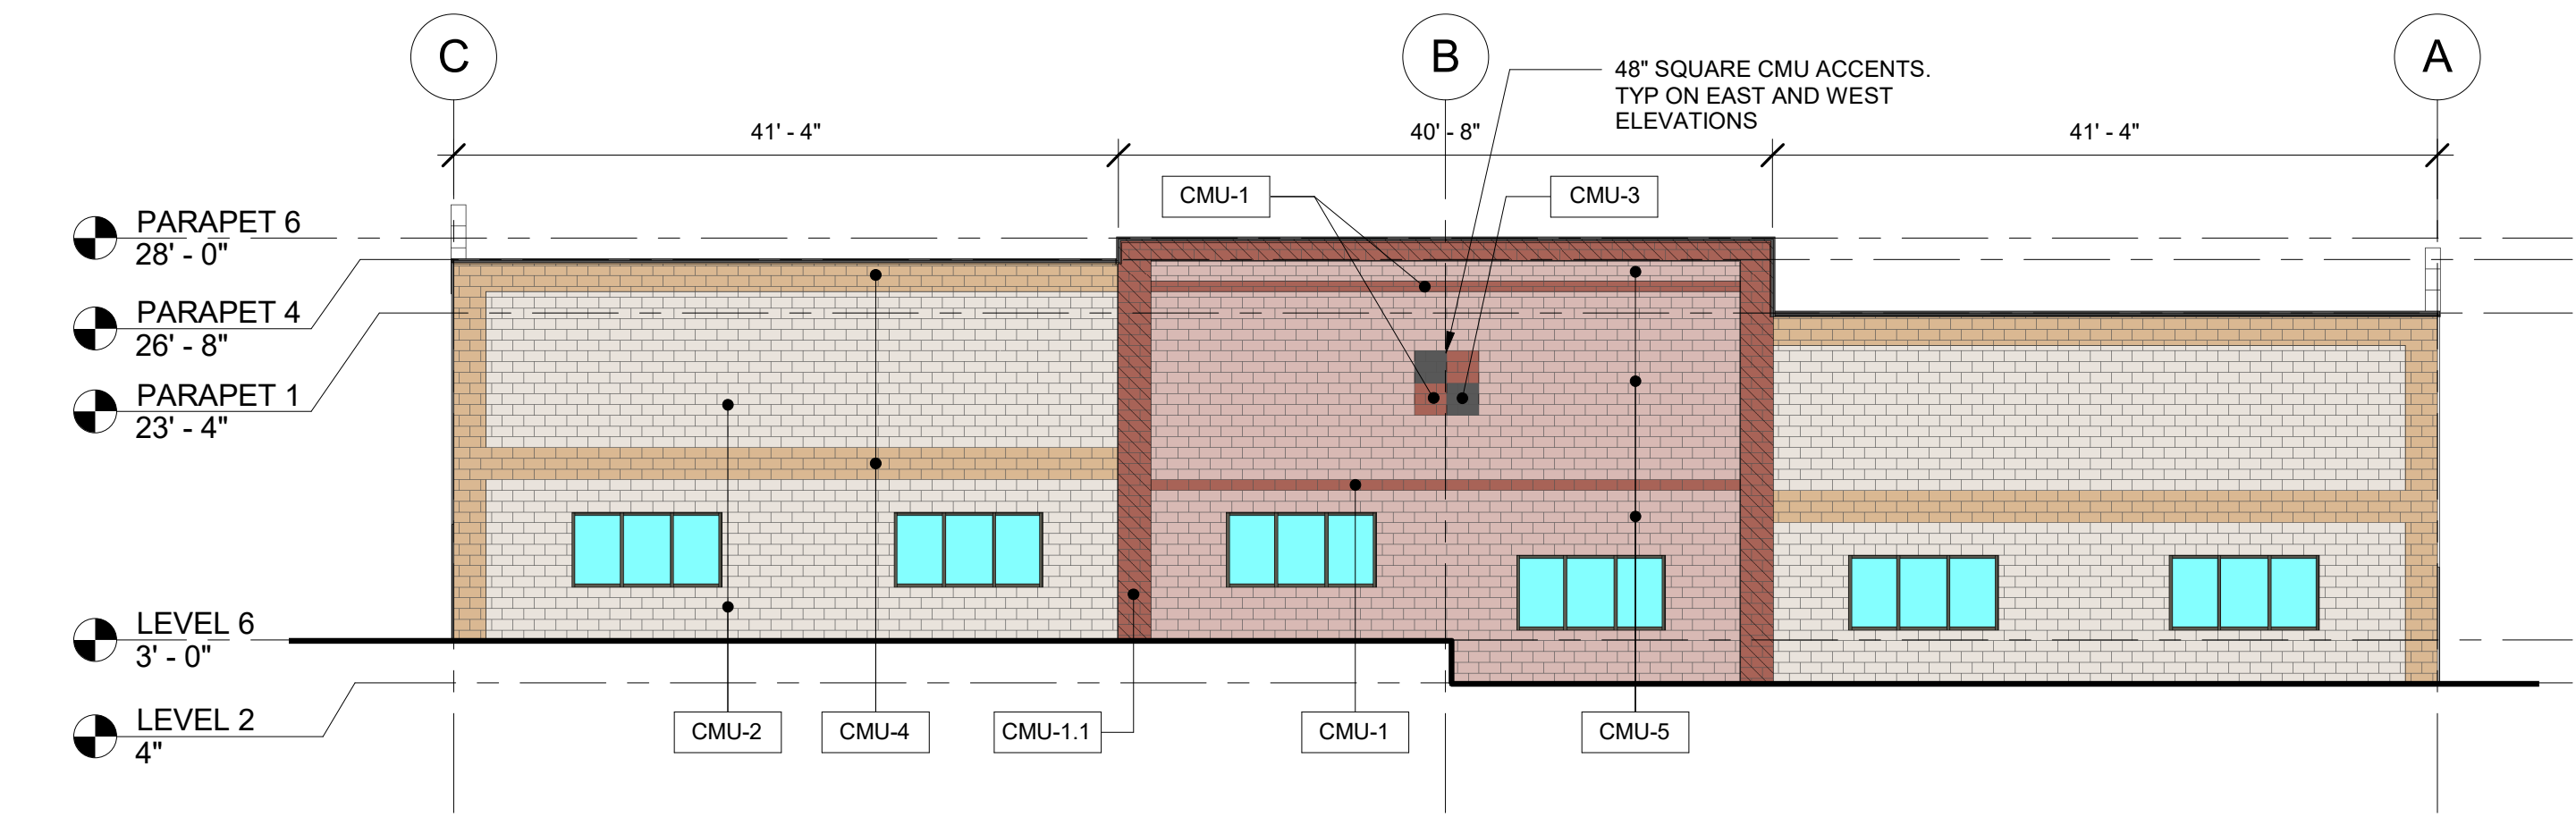


4 WEST ELEVATION
3/32" = 1'-0"

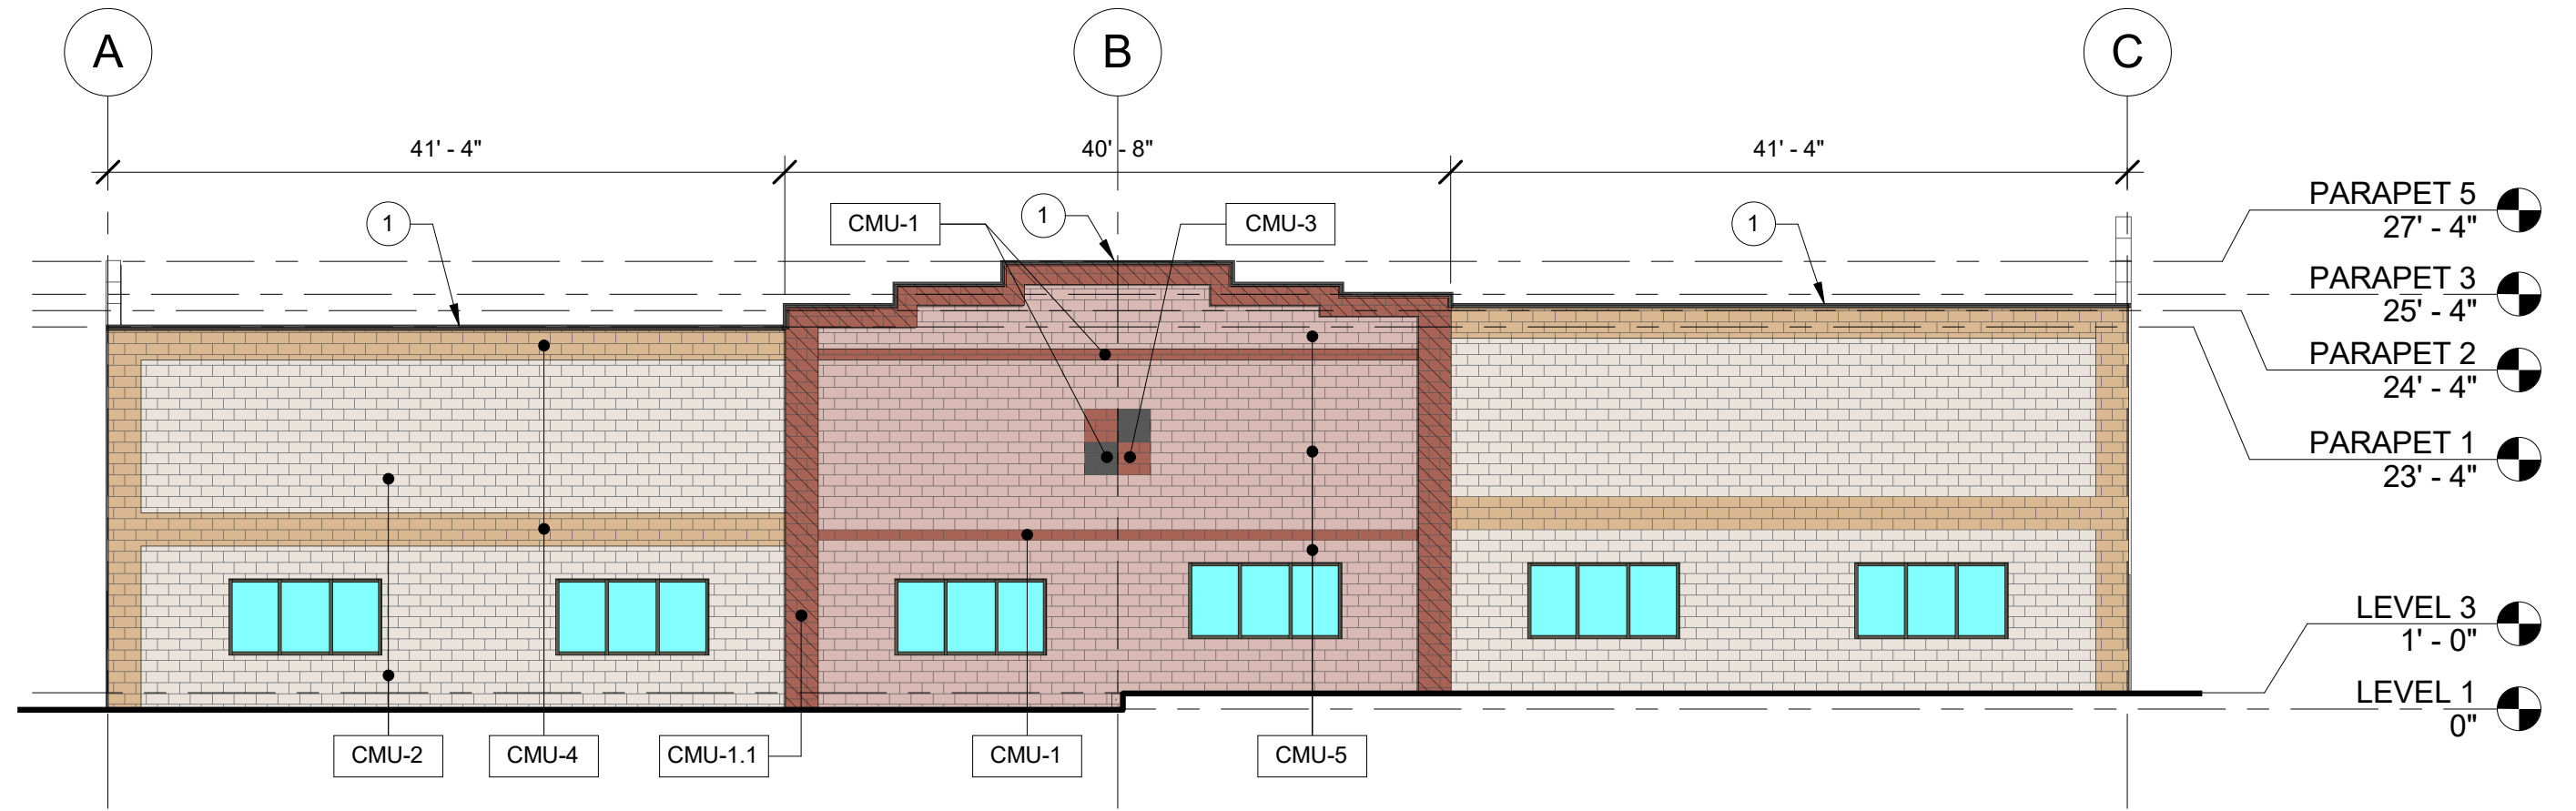

1 EAST ELEVATION
3/32" = 1'-0"

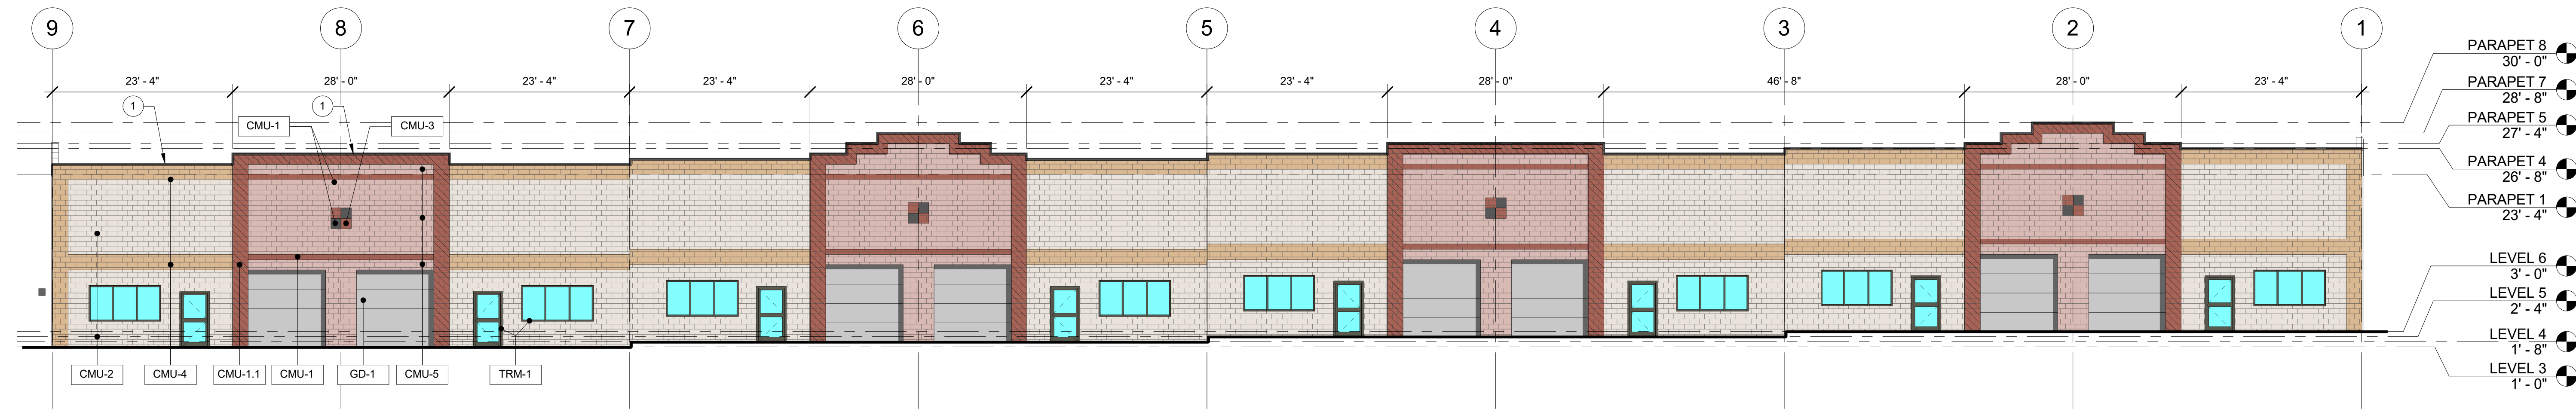

2 NORTH ELEVATION
3/32" = 1'-0"

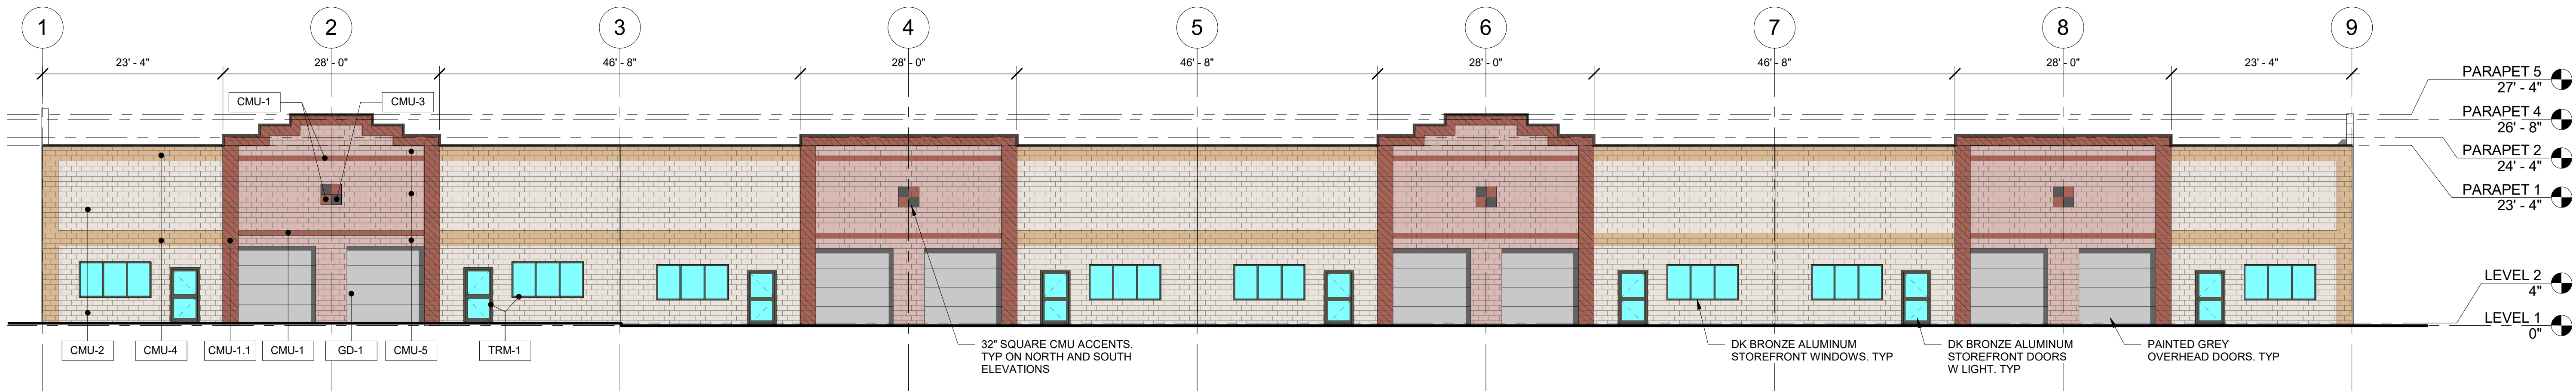

3 SOUTH ELEVATION
3/32" = 1'-0"

CMU LEGEND	ELEVATION NOTES
 CMU-1 (RED)  CMU-1.1 (RED, 10" BLOCK)  CMU-2 (MEDIUM WHITE)  CMU-3 (CHARCOAL)  CMU-4 (SADDLE BROWN)  CMU-5 (PINK RUBY)	1 PREFINISHED METAL PARAPET CAP. TRM-1 DARK BRONZE REFER TO MATERIAL BOARDS FOR ADDITIONAL EXTERIOR MATERIAL AND COLOR INFO

Kenny Davis Architects

1638 South Brentwood, Lakewood, Colorado, 80232 Tel: 303-965-5813

professional seal

Copyright Notice: This document and the ideas and designs incorporated herein are given in confidence and shall be used only pursuant to the agreement with Kenny Davis Architects. No other use, dissemination or duplication may be made without prior written consent of Kenny Davis Architects. All common law rights of copyright are hereby specifically reserved.

consultant

MOTHERLODE BLDG
BLOCK 1 LOT 2 CTC, FIRST FILING
745 PIERCE AVE.
LOUISVILLE CO 80027

REVISIONS:	
△	
△	
△	
△	
△	

DRAWN BY: CHECKED BY:

KDA KDA

DATE: 2020-01-06

PHASE: PUD

JOB NUMBER: 2019045


DRAWING TITLE: ELEVATIONS


DRAWING NUMBER:


SHEET 6 OF 10

LANDSCAPE REQUIREMENTS		
TOTAL LOT SIZE:		94,419
TOTAL AREA NOT COVERED BY BUILDING, PARKING LOT OR PATIO		23,403
	REQUIRED	PROPOSED
TOTAL NUMBER OF PARKING STALLS	74	74 spaces
TOTAL NUMBER OF PARKING LOT TREES	21	22
TOTAL NUMBER OF STREET TREES	10.5	10
TOTAL NUMBER OF PERIMETER TREES	23	23
TOTAL QUANTITY OF PLANT MATERIAL ON SITE PLAN (TREES AND SHRUBS)		210
TOTAL QUANTITY OF TURF & SEEDD AREAS		19,677
TOTAL QUANTITY OF TREES AND SHRUB BEDS		3,726

LEGEND:

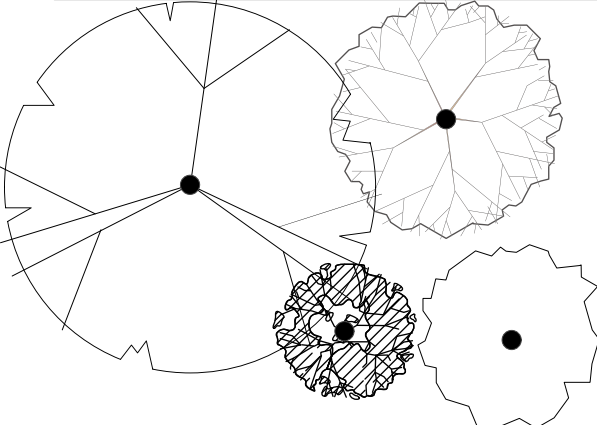
 PROPOSED SHADE TREES

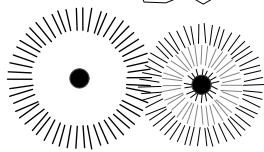 PROPOSED ORNAMENTAL TREES

  PROPOSED EVERGREEN TREES

 PROPOSED SHRUBS

  PROPOSED PERENNIALS

 FESCUE TURF

 LOW GROW SEED MIX
(per Arkansas Valley Seed)



 RAIN GARDEN SAND

 CRUSHER FINE SURFACE

 ROLL TOP STEEL EDGER

 BIKE RACKS

 CONCRETE WALK

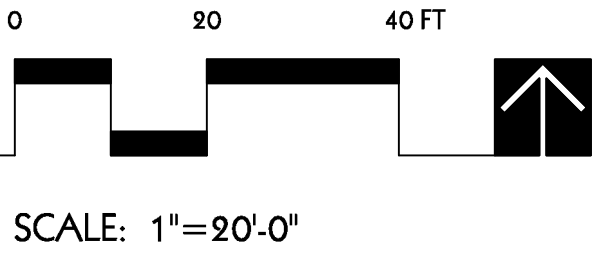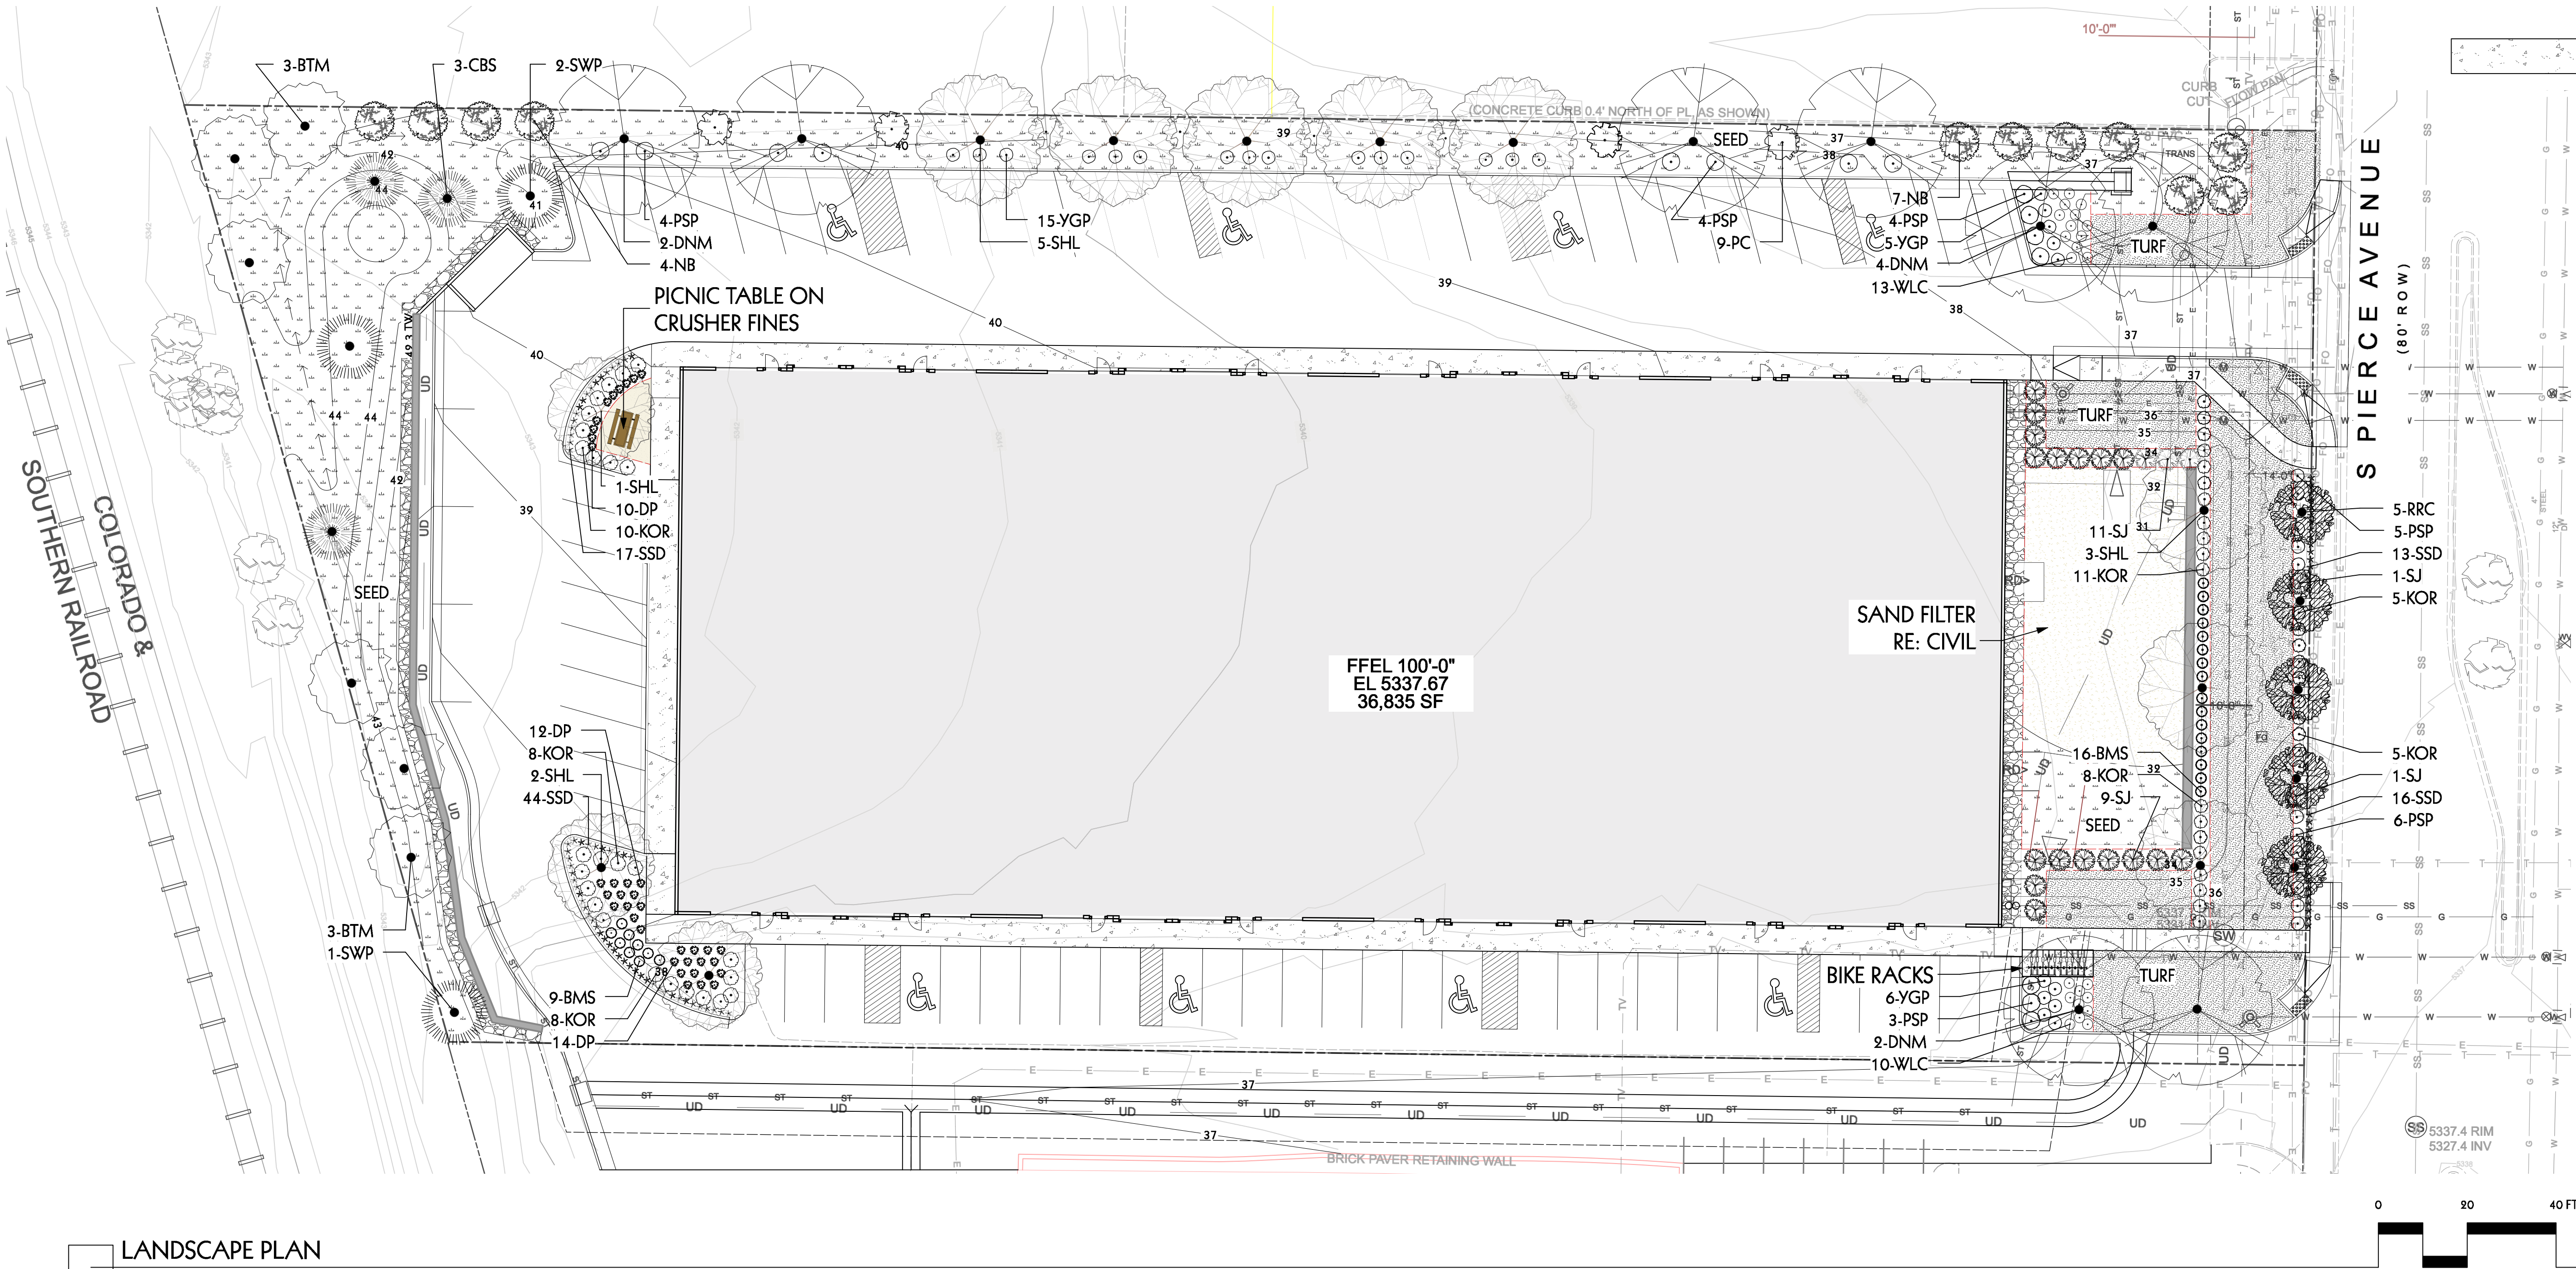




landscape architecture +
urban design +
planning

booulder / steamboat springs, co

p. 303.517.8258

f. 303.517.8160

outside@me.com

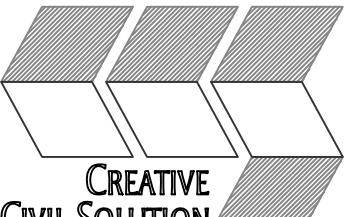

CREATIVE
CIVIL SOLUTION

940 Kimbark Street, Suite 2
Longmont, Colorado 80501
303-684-8484

Building

Block 1 Lot 2
COLORADO
TECHNOLOGICAL
CENTER, FIRST FILING

745 Pierce Ave
Louisville, CO 80027

PROJ NO: REV

19010
DATE

PUD FORMAL: 1

1.6.2020


LANDSCAPE PLAN

7

SHEET 7 OF 10

PLANT SCHEDULE - 1/3/19				
ABBREV	SCIENTIFIC NAME	COMMON NAME	SIZE	QTY
CANOPY TREES:				
DNM	Acer platanoides 'Deborah'	Deborah Norway Maple	2.5" cal.	8
SHL	Gleditsia triacanthos var. inermis 'Shademaster'	Shademaster Honeylocust	2.5" cal.	11
			TOTAL	19
EVERGREEN TREES:				
CBS	Picea pungens 'Baby Blue Eyes'	Baby Blue Eyes Spruce	6'-8' ht.	3
SWP	Pinus strobiformus	Southwestern White Pine	6'-8' ht.	3
			TOTAL	6
ORNAMENTAL TREES:				
BTM	Acer grandidentatum	Bigtooth Maple	2" cal	6
RRC	Malus Royal Raindrops	Royal Raindrops Crabapple	2" cal	5
			TOTAL	11
SHRUBS:				
BMS	Caryopteris x clandonensis 'Dark Knight'	Dark Knight Spirea	5 gal.	25
KOR	Rosa x 'Knock Out'	Knock Out Rose	5 gal.	55
NB	Viburnum lentago	Nannyberry Viburnum	5 gal.	11
PC	Cotoneaster lucidus	Peking Cotoneaster	5 gal.	9
PSP	Potentilla fruticosa davurica 'Prairie Snow'	Prairie Snow Potentilla	5 gal.	26
SJ	Juniperus sabina 'Scandia'	Scandia Juniper	5 gal.	22
YGP	Potentilla fruticosa 'Yellow Gem'	Yellow Gem Potentilla	5 gal.	26
			TOTAL	174
PERENNIALS:				
DP	Ceratostigma plumbaginoides	Dwarf Plumbago	1 gal.	36
SSD	Leucanthemum x superbum 'Silver Princess'	Snowlady Shasta Daisy	1 gal.	90
WLC	Nepeta x faassenii 'Walker's Low'	Walker's Low Catmint	1 gal.	23
			TOTAL	149

Native Seed Mix		
Common Name	Scientific Name	Lb/ac (PLS)*
Western wheatgrass	Pascopyrum smithii	3.5
Slender wheatgrass	Elymus trachycaulus	4
Sidecoats grama	Bouteloua curtipendula	3
Blue grama	Bouteloua gracilis	1
Little bluestem	Schizachyrium scoparium	2
Needle and thread grass	Hesperostipa comata	2
Sand dropseed	Sporobolus cryptandrus	0.02
Total		15.52
* Please note that the pounds per acre are in PLS (Pure Live Seed) and must be ordered that way.		
* This mix is based on 7.5 seeds/ square foot and is only calculated for one acre. This mix is based on the contractor using a drill seed application. Contractor is responsible for calculating the appropriate seed amounts to purchase. Mix should be doubled if hand applied.		

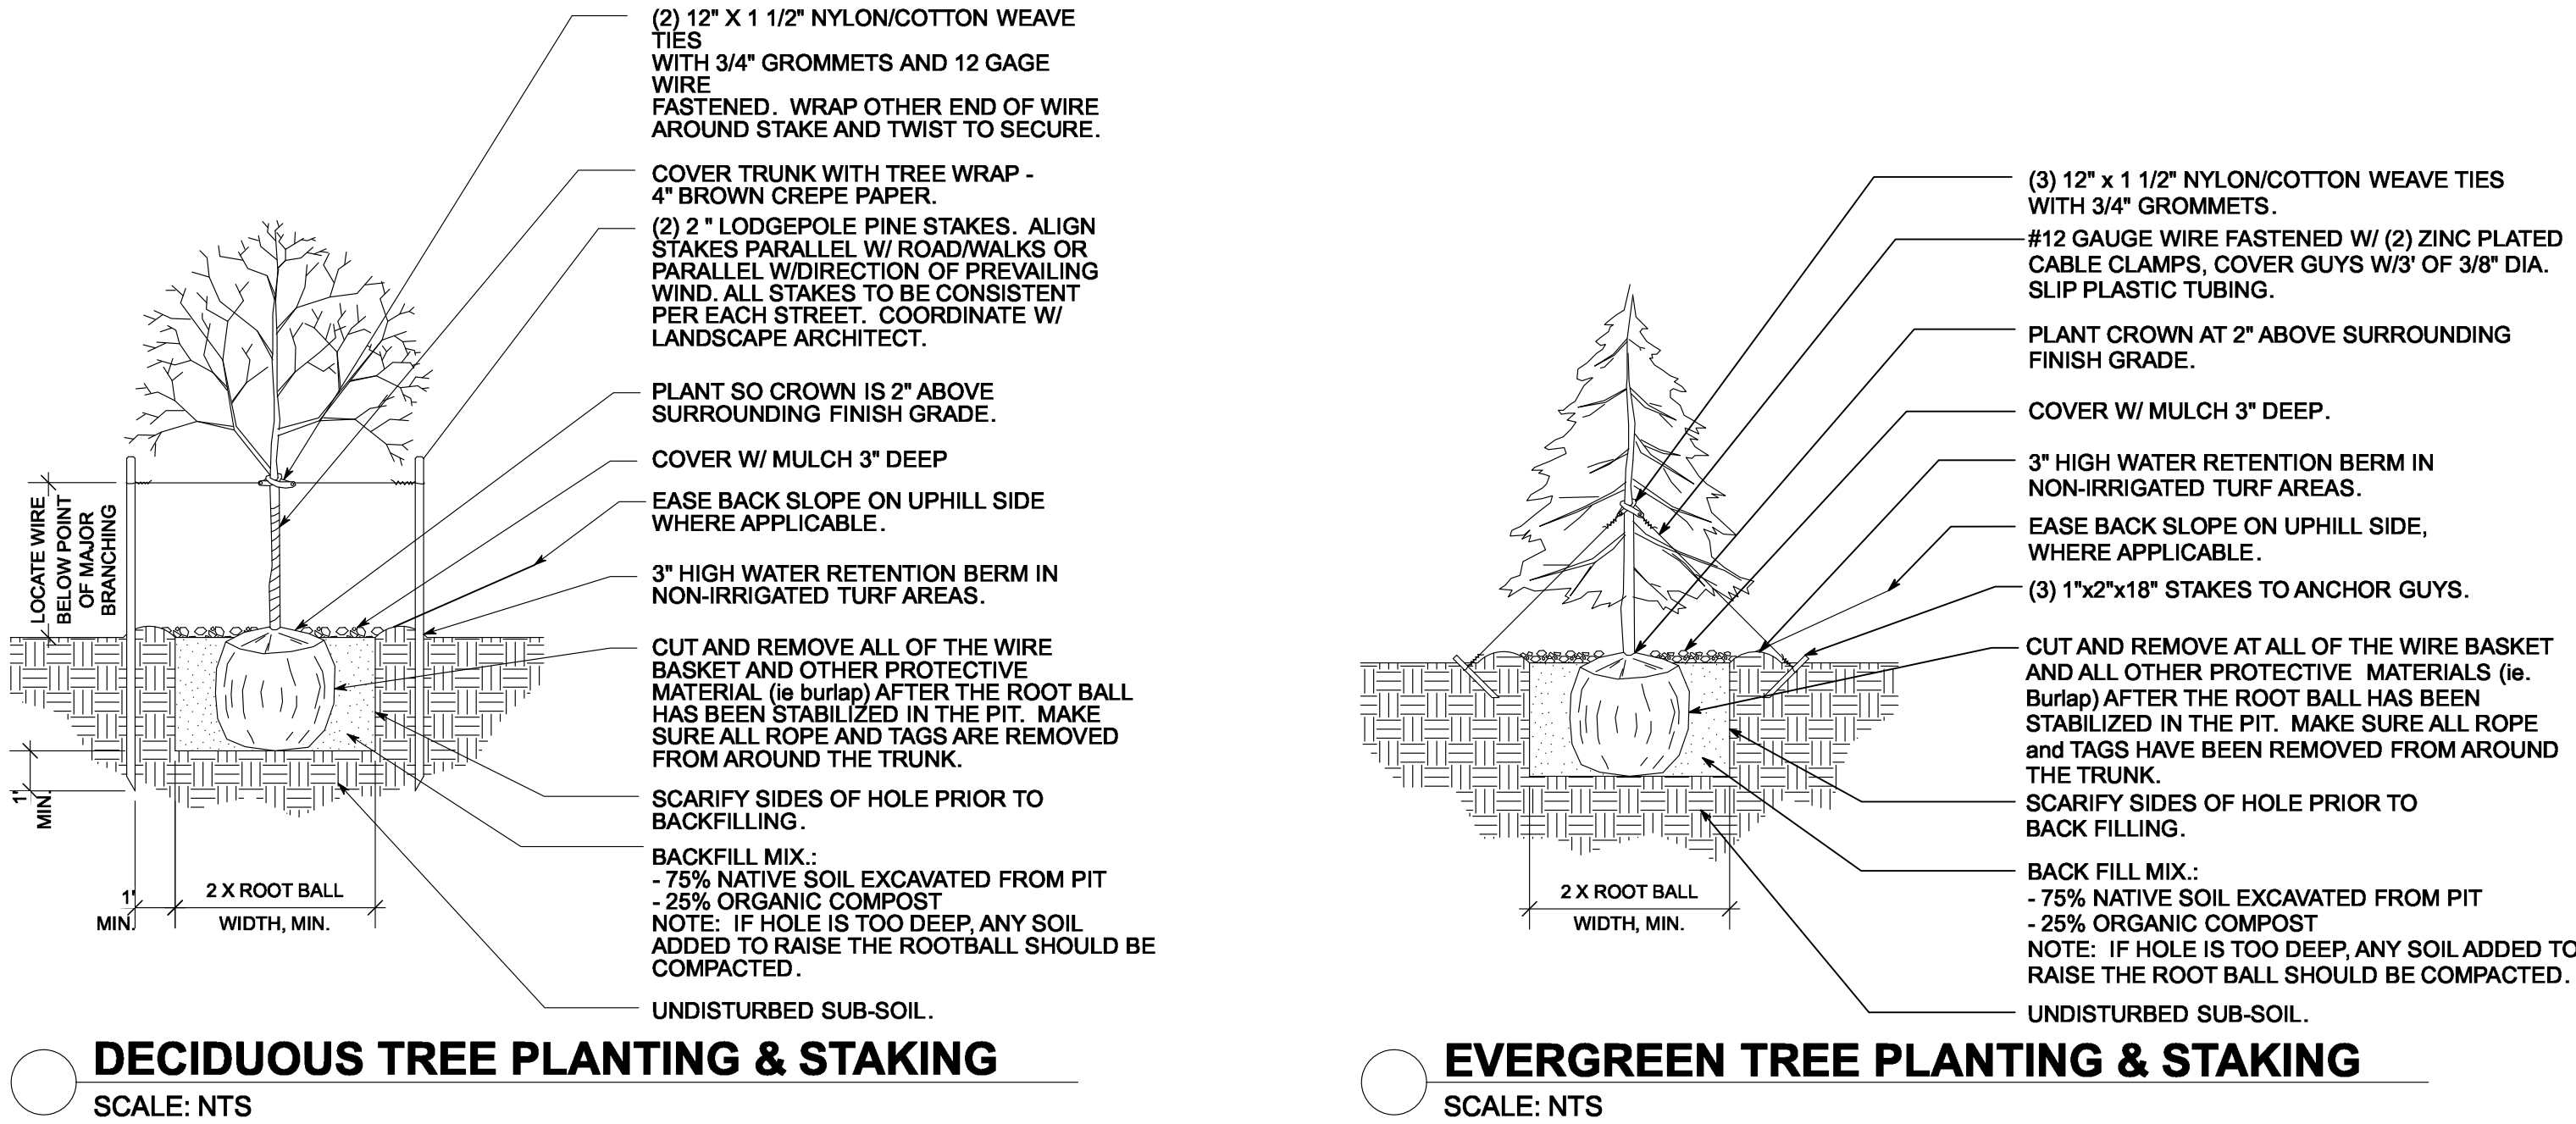

PLANT NOTES:

REFERENCE: CITY OF LOUISVILLE, INDUSTRIAL DEVELOPMENT DESIGN STANDARDS AND GUIDELINES (IDDSG) , JANUARY, 2000.

- GRADES SHALL BE SET TO ALLOW FOR PROPER DRAINAGE AWAY FROM ALL STRUCTURES. GRADES SHALL MAINTAIN SMOOTH PROFILES AND BE FREE OF SURFACE DEBRIS, BUMPS, AND DEPRESSIONS.
- REFER TO CIVIL ENGINEERING DRAWINGS FOR GRADING AND UTILITIES.
- DEVELOPERS SHALL ENSURE THAT THE LANDSCAPE PLANS COORDINATED WITH THE PLANS DONE BY OTHER CONSULTANTS SO THAT THE PROPOSED GRADING, STORM DRAINAGE, OR OTHER CONSTRUCTION DOES NOT CONFLICT NOR PRECLUDE INSTALLATION AND MAINTENANCE OF LANDSCAPE ELEMENTS ON THIS PLAN.
- DURING CONSTRUCTION, PREVENT CLEANING OF EQUIPMENT, THE STORAGE OR DISPOSAL OF WASTE BUILDING MATERIAL (I. E. PAINT, OILS, SOLVENTS, ASPHALT, CONCRETE, MORTAR) WITHIN THE DRIPLINE OF ANY PROTECTED TREE OR GROUPS OF TREES.
- SITE PREPARATION & ALL PLANTING MUST BE COMPLETED IN ACCORDANCE WITH CHAPTERS 1 & 5 OF 1DDGS. PRIOR TO INSTALLATION OF PLANT MATERIAL, AREAS THAT HAVE BEEN COMPACTED OR DISTURBED BY CONSTRUCTION ACTIVITY SHALL BE THOROUGHLY LOOSENEED, ORGANIC AMENDMENTS SUCH AS COMPOST, PEAL, OR AGED MANURE SHALL BE THOROUGHLY INCORPORATED AT THE RATE OF AT LEAST THREE (3) CUBIC YARDS OF AMENDMENT PER 1000 SQUARE FEET OF LANDSCAPE AREA.
- ALL TREES & SHRUBS SHOWN AT APPROXIMATELY 2/3 OF MATURE SIZE.
- CONTRACTOR SHALL VERIFY ALL MATERIALS QUANTITIES PRIOR TO INSTALLATION. ACTUAL NUMBER OF SYMBOLS SHALL HAVE PRIORITY OVER THE QUANTITY DESIGNATED.
- LABELS THAT INDENTIFY THE BOTANICAL OR COMMON NAME WILL BE ON ALL TREES AT THE FINAL INSPECTION.
- ALL PLANT MATERIALS WILL MEET THE FOLLOWING MINIMUM SIZES, AS NOTED IN SECT. 5-7:
 - DECIDUOUS SHADE/CANOPY TREES: 2.5" CALIPER
 - ORNAMENTAL: 2.0" CALIPER*
 - EVERGREEN TREES: 6'-8' HEIGHT (WITH A MINIMUM OF 25% 8' IN HEIGHT)
 - MULTI-STEM ORNAMENTALS: 8'-10' HEIGHT
 - SHRUBS: 5 GALLON CONTAINER
 - GROUND COVER/PERENNIALS: 2-1/4" POTS
 - VINES: 1 GALLON CONTAINER
- ALL PLANT MATERIAL SHALL MEET SPECIFICATIONS OF THE AMERICAN ASSOCIATION OF NURSERYMEN (AAN) FOR NUMBER ONE GRADE. ALL TREES SHALL BE BALLED AND BURLAPPED OR EQUIVALENT.
- DECIDUOUS TREES SHALL BE PLANTED A MINIMUM OF 5- FEET AND EVERGREEN TREES A MINIMUM OF 10- FEET FROM PUBLIC UTILITIES AND PUBLIC SIDEWALKS, UNLESS MODIFIED BY PUD STREET TREE PLANS. TREE PLANTING SHALL BE COORDINATED WITH PUBLIC SERVICE COMPANY. LOCATION OF ALL UTILITIES SHALL BE VERIFIED IN THE FIELD PRIOR TO PLANTING. A HORIZONTAL DISTANCE OF 40' BETWEEN STREET TREE AND STREET LIGHT SHALL BE MAINTAINED.
- TEMPORARY MULCH WILL BE INSTALLED IN SHRUB, TREE, AND PERENNIAL PLANTING BEDS UNTIL FULL PLANT COVERAGE IS ACHIEVED.
- PERMANENT MULCH, ASPEN-PINE, 3" DEEP, WILL BE INSTALLED IN SHRUB, TREE, AND PERENNIAL PLANTING BEDS WHERE THERE IS NO GROUND COVER SPECIFIED.
- THE PROPERTY OWNER IS RESPONSIBLE FOR PROVIDING, PROTECTING AND MAINTAINING ALL LANDSCAPING IN A HEALTHY AND GROWING CONDITION, AND ADHERE TO ALL STANDARDS OF GUIDELINES OF SECTION 5.8 OF IDDSG. THE PROPERTY OWNER WILL REMOVE AND REPLACE DEAD PLANT MATERIALS IMMEDIATELY WITH THE SAME TYPE, SIZE AND QUANTITY OR PLANT MATERIAL AS ORIGINALLY INSTALLED, UNLESS MATERIAL IS DISEASED OR INSECT-INFECTED.
- ALL LANDSCAPE AREAS WILL BE IRRIGATED WITH PERMANENT AUTOMATIC IRRIGATION SYSTEM DESIGNED TO PROVIDE EFFICIENT IRRIGATION COVERAGE WITH MINIMAL OVER SPRAY ONTO NON-LANDSCAPED AREAS.
- A SOIL SENSING DEVICE OR OTHER IRRIGATION MANAGEMENT SYSTEM WILL BE INSTALLED FOR IRRIGATION SYSTEMS IN TURF AREAS.
- ALL SOD AREAS UNLESS OTHERWISE NOTED WILL BE SODDED WITH LOW-WATER DEMANDING BLEND. SEEDED AREAS UNLESS OTHERWISE NOTES WILL BE SEEDED WITH DRYLAND / NATIVE SEED TO SUIT SPECIFIC SOIL CONDITION AND MAINTANCE REQUIREMENTS.

landscape architecture +
urban design +
planning

boulder / steamboat springs, co
p. 303.517.8226
f. 970.387.5169
oala@me.com

CREATIVE
CIVIL SOLUTION
940 Kimbark Street, Suite 2
Longmont, Colorado 80501
303-684-8484

Building

Block 1 Lot 2
COLORADO
TECHNOLOGICAL
CENTER, FIRST FILING


745 Pierce Ave
Louisville, CO 80027

PROJ NO: REV19010
PUD FORMAL: 1DATE
1.6.2020

LANDSCAPE NOTES &
DETAILS

8

SHEET 8 OF 10

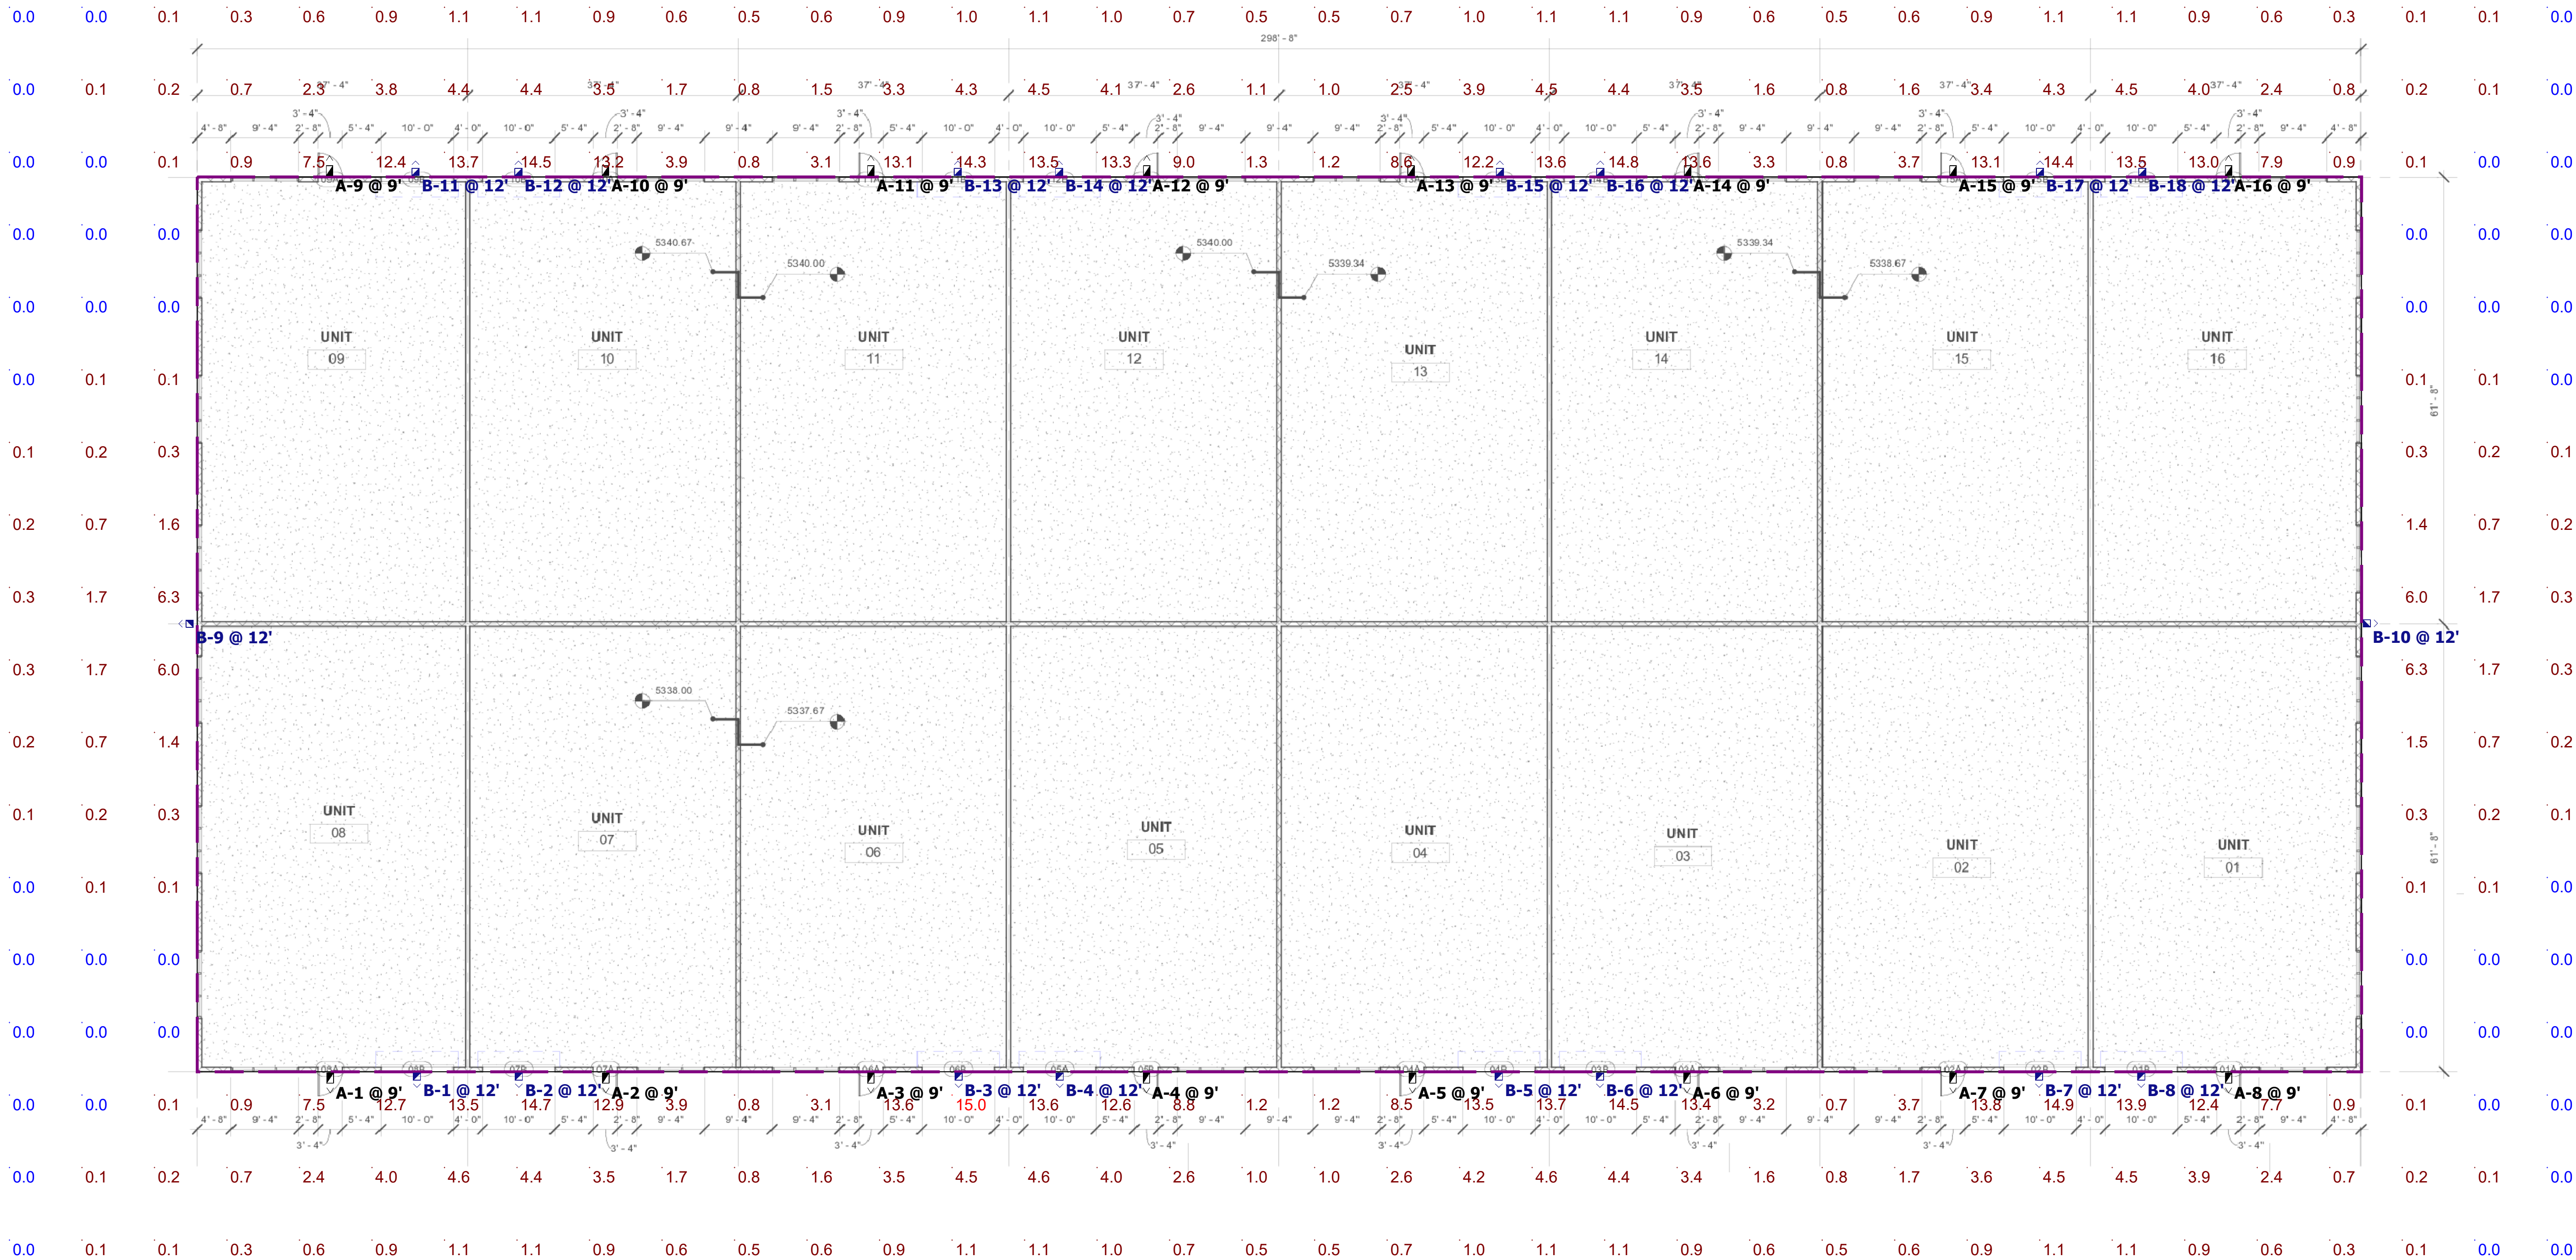

Plan View
Scale - 1" = 12ft

Schedule										
Symbol	Label	QTY	Manufacturer	Catalog Number	Description	Number Lamps	Filename	Lumens per Lamp	LLF	Wattage
	A	16	TAI2HOU JIAOQUANG LIGHTING CO.,LTD	WP403-18W-50K-PC-BR	Outdoor Non-Cutoff and Semi-Cutoff Wall-Mounted Area	1	#1 Luxrite-18W flood wallpack40600.IES	2256	0.95	17.15
	B	18	Shenzhen Vanplex Optoelectronics Co., Ltd	WP403-18W-50K-PC-BR	VPL-WPS-36WAN-YIK	1	#2 LED Wall Pack 36W IES(2).IES	3607	0.95	37.3


Statistics						
Description	Symbol	Avg	Max	Min	Max/Min	Avg/Min
Calc Zone #1	+	2.8 fc	15.0 fc	0.0 fc	N/A	N/A

- Notes**
- Readings are shown in units of maintained footcandles.
 - Total Light Loss Factor (LLF) = .95 LLF for LED
 - Test Plane = 0' Above grade
 - Fixture Mounting Height = See Plan View
 - Fixture Spacing = See Plan view.
 - This photometric layout was calculated using specific criteria. Any deviation from stated parameters will affect actual performance.
 - These lighting calculations are not a substitute for independent engineering analysis of lighting system suitability and safety.

Disclaimer
This lighting design is not a professional engineering drawing and is provided for informational purposes only, without warranty as to accuracy, completeness, reliability or otherwise. Frazier Photometrics is not responsible for specifying the lighting or illumination requirements for any specific project. It is the obligation of the end-user to consult with a professional engineering advisor to determine whether this lighting design meets the applicable project requirements for lighting system performance, safety, suitability and effectiveness for use in a particular application. End-user environment and application (including, but not limited to, voltage variation and dirt accumulation) can cause actual field performance to differ from the calculated photometric performance represented in this lighting design. In no event will Frazier Photometrics be held responsible for any loss resulting from any use of this lighting design.

Designer
KF
Date
1/4/2020
Scale
As Shown
Drawing No.
10500120A1
Summary

SPECIFICATIONS									
ELECTRICAL									
MODEL	DESCRIPTION	POWER	INPUT VOLTS	DIMMABLE	EFFICACY (LPW)	FREQUENCY	THD	POWER FACTOR	
LR40600	LEDWPC18/ 50K/PC/UNV/B	18	120-277V	NO	122	50/ 60Hz	<20%	>0.9	
LR40610	LEDWPC26/ 50K/PC/UNV/B	26	120-277V	NO	122	50/ 60Hz	<20%	>0.9	
PHOTOMETRIC					GENERAL				
MODEL	COLOR (CCT)	TEMP	LUMEN	CRI	SHAPE	WET LOCATION	COST/YR	ETL LISTED	DLC LISTED
LR40600	5000K	BRIGHT WHITE	2200	70	LED WALL PACK CUBE	YES	\$ 2.17	YES	PL7X3QZK062V
LR40610	5000K	BRIGHT WHITE	3000	70	LED WALL PACK CUBE	YES	\$ 3.13	YES	PLVT4LZT03B
DIMENSIONS									

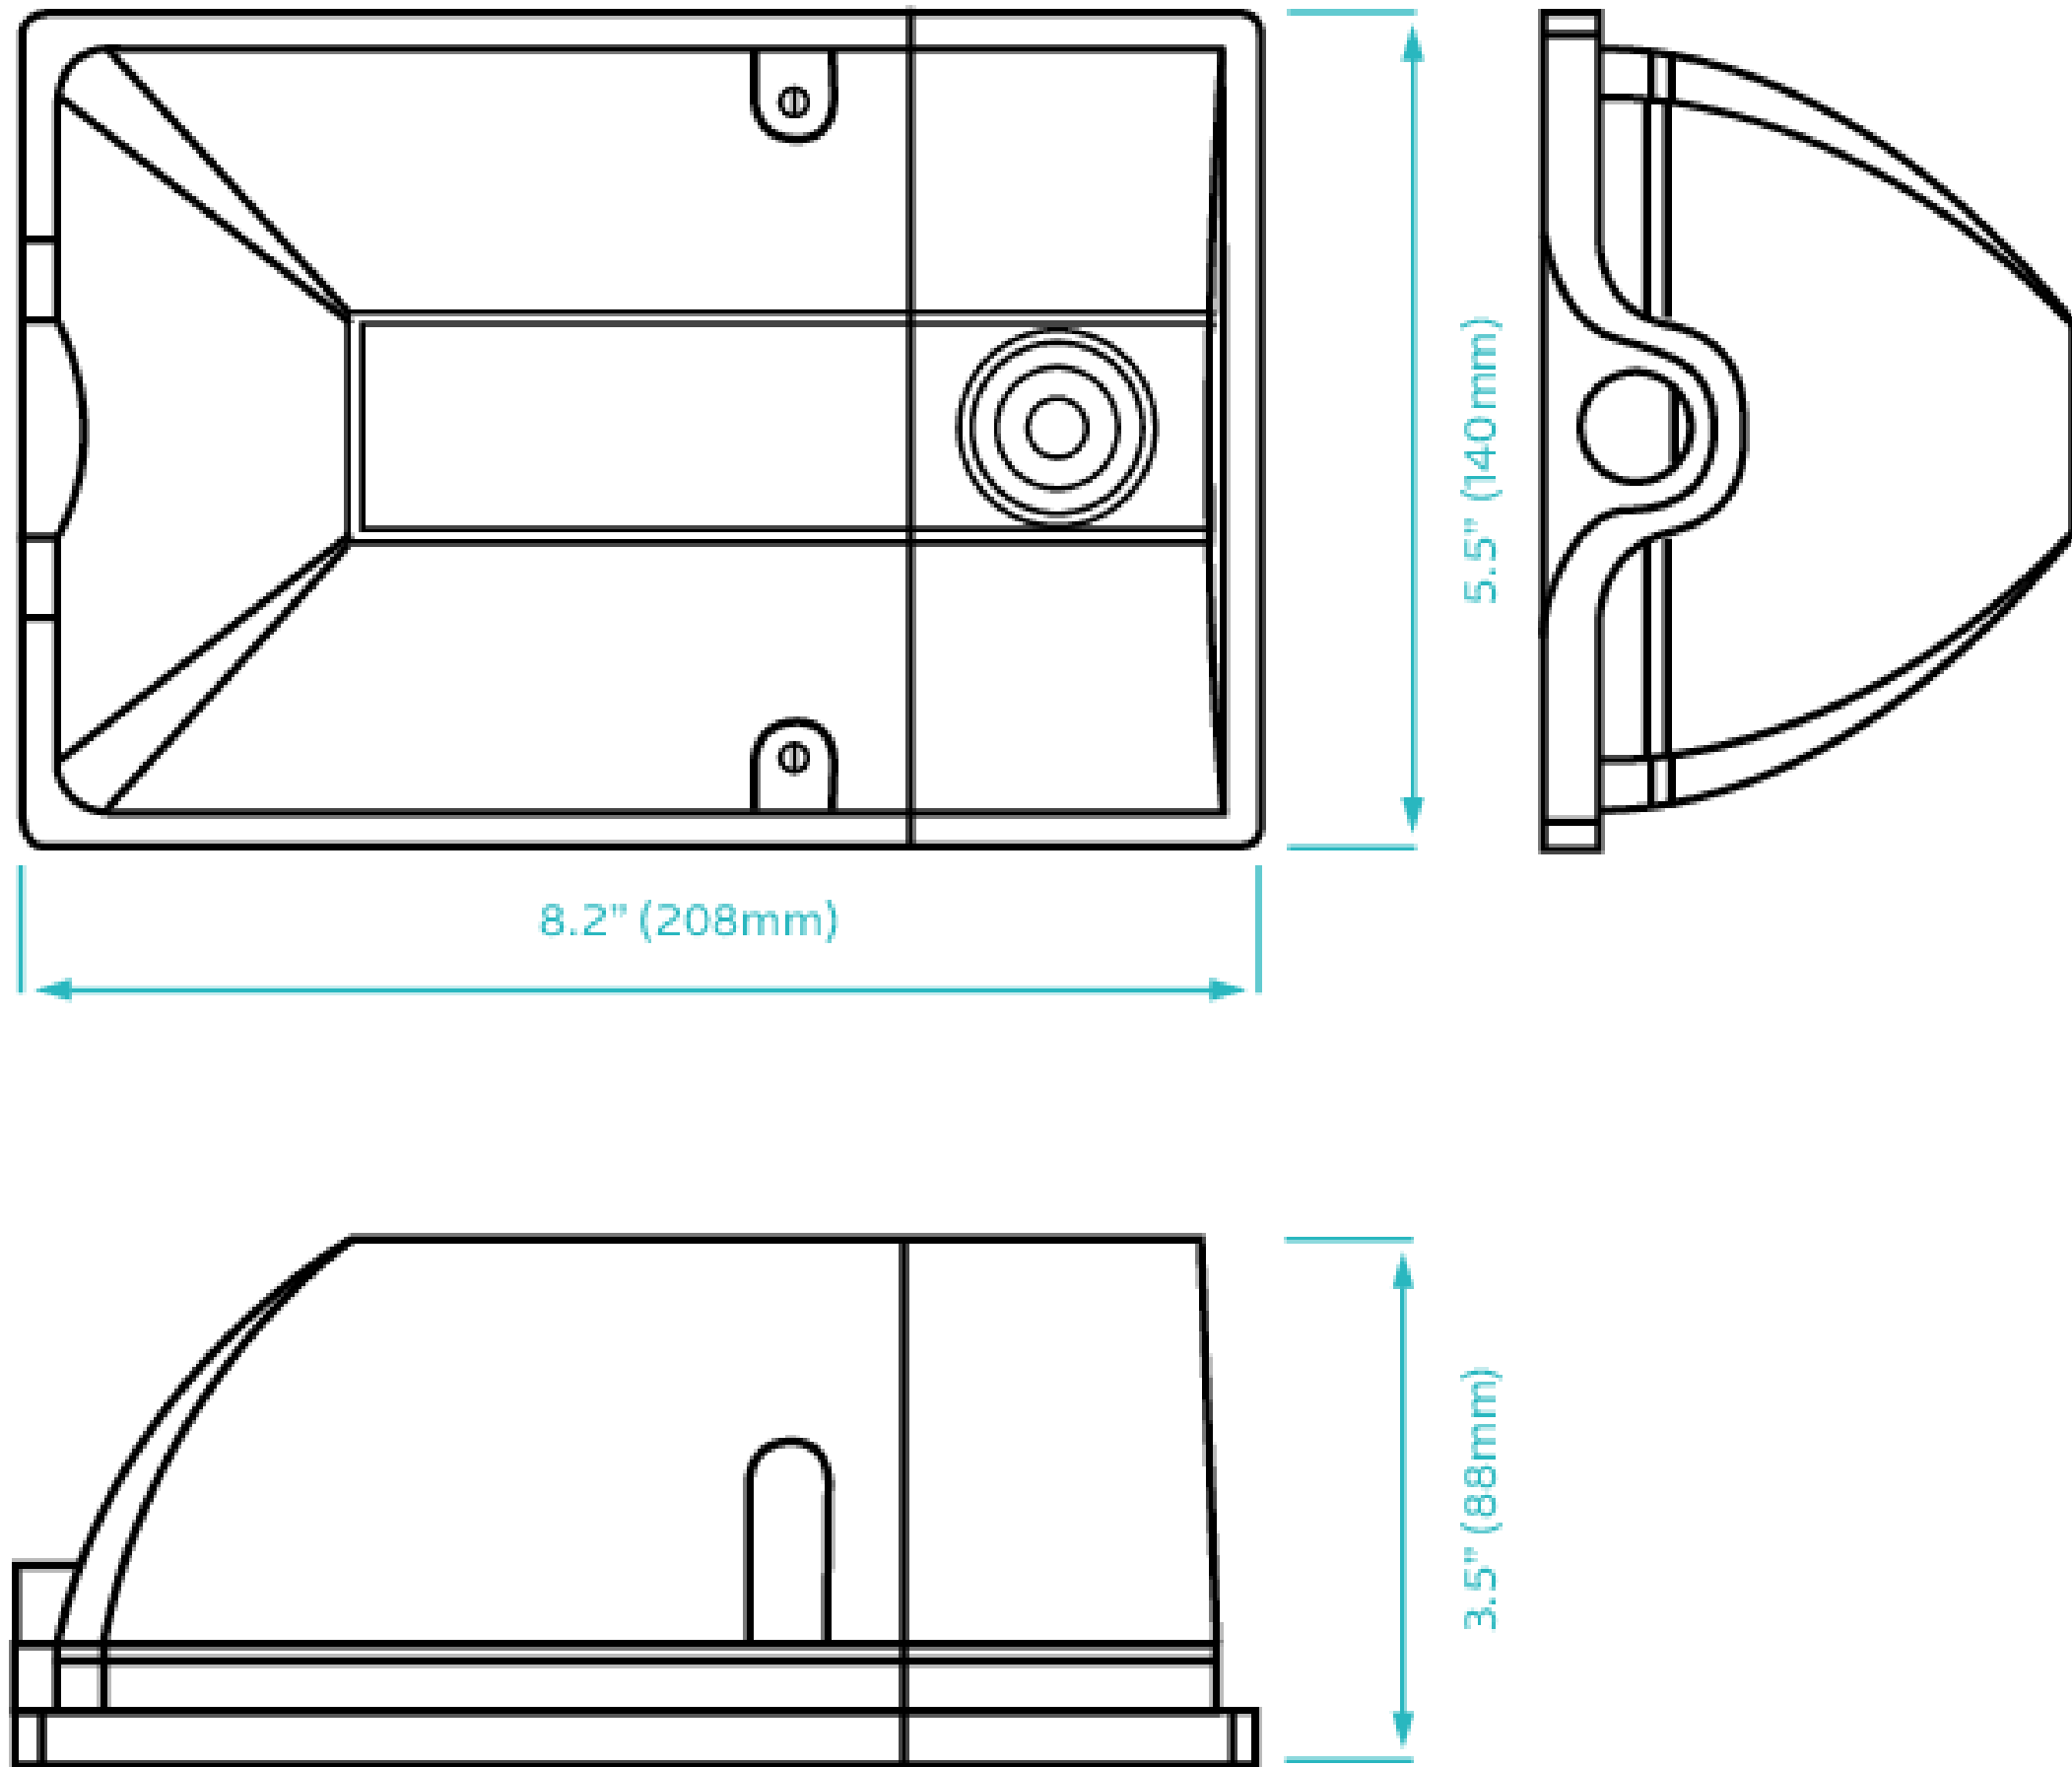

SPECIFICATIONS									
ELECTRICAL									
MODEL	DESCRIPTION	POWER	INPUT VOLTS	DIMMABLE	EFFICACY (LPW)	FREQUENCY	THD	POWER FACTOR	
LR40500	LEDWP45/50K/PC/UNV/B	45	120-277V	0-10V	114	50/60Hz	<20%	>0.95	
LR40510	LEDWP60/50K/PC/UNV/B	60	120-277V	0-10V	118	50/60Hz	<20%	>0.95	
LR40520	LEDWP80/50K/PC/UNV/B	80	120-277V	0-10V	118	50/60Hz	<20%	>0.95	
PHOTOMETRIC					GENERAL				
MODEL	COLOR (CCT)	TEMP	LUMEN	CRI	SHAPE	WET LOCATION	COST/YR	ETL LISTED	DLC LISTED
LR40500	5000K	BRIGHT WHITE	5120	70	DOB LED WALLPACK	YES	\$ 5.42	YES	PLMTJDSLAL59
LR40510	5000K	BRIGHT WHITE	7085	70	DOB LED WALLPACK	YES	\$ 7.23	YES	PLN7VHAP1NHO
LR40520	5000K	BRIGHT WHITE	9450	70	DOB LED WALLPACK	YES	\$ 9.64	YES	PLKNI9E9QVC3
DIMENSIONS									

